



# EXHIBIT HALL C

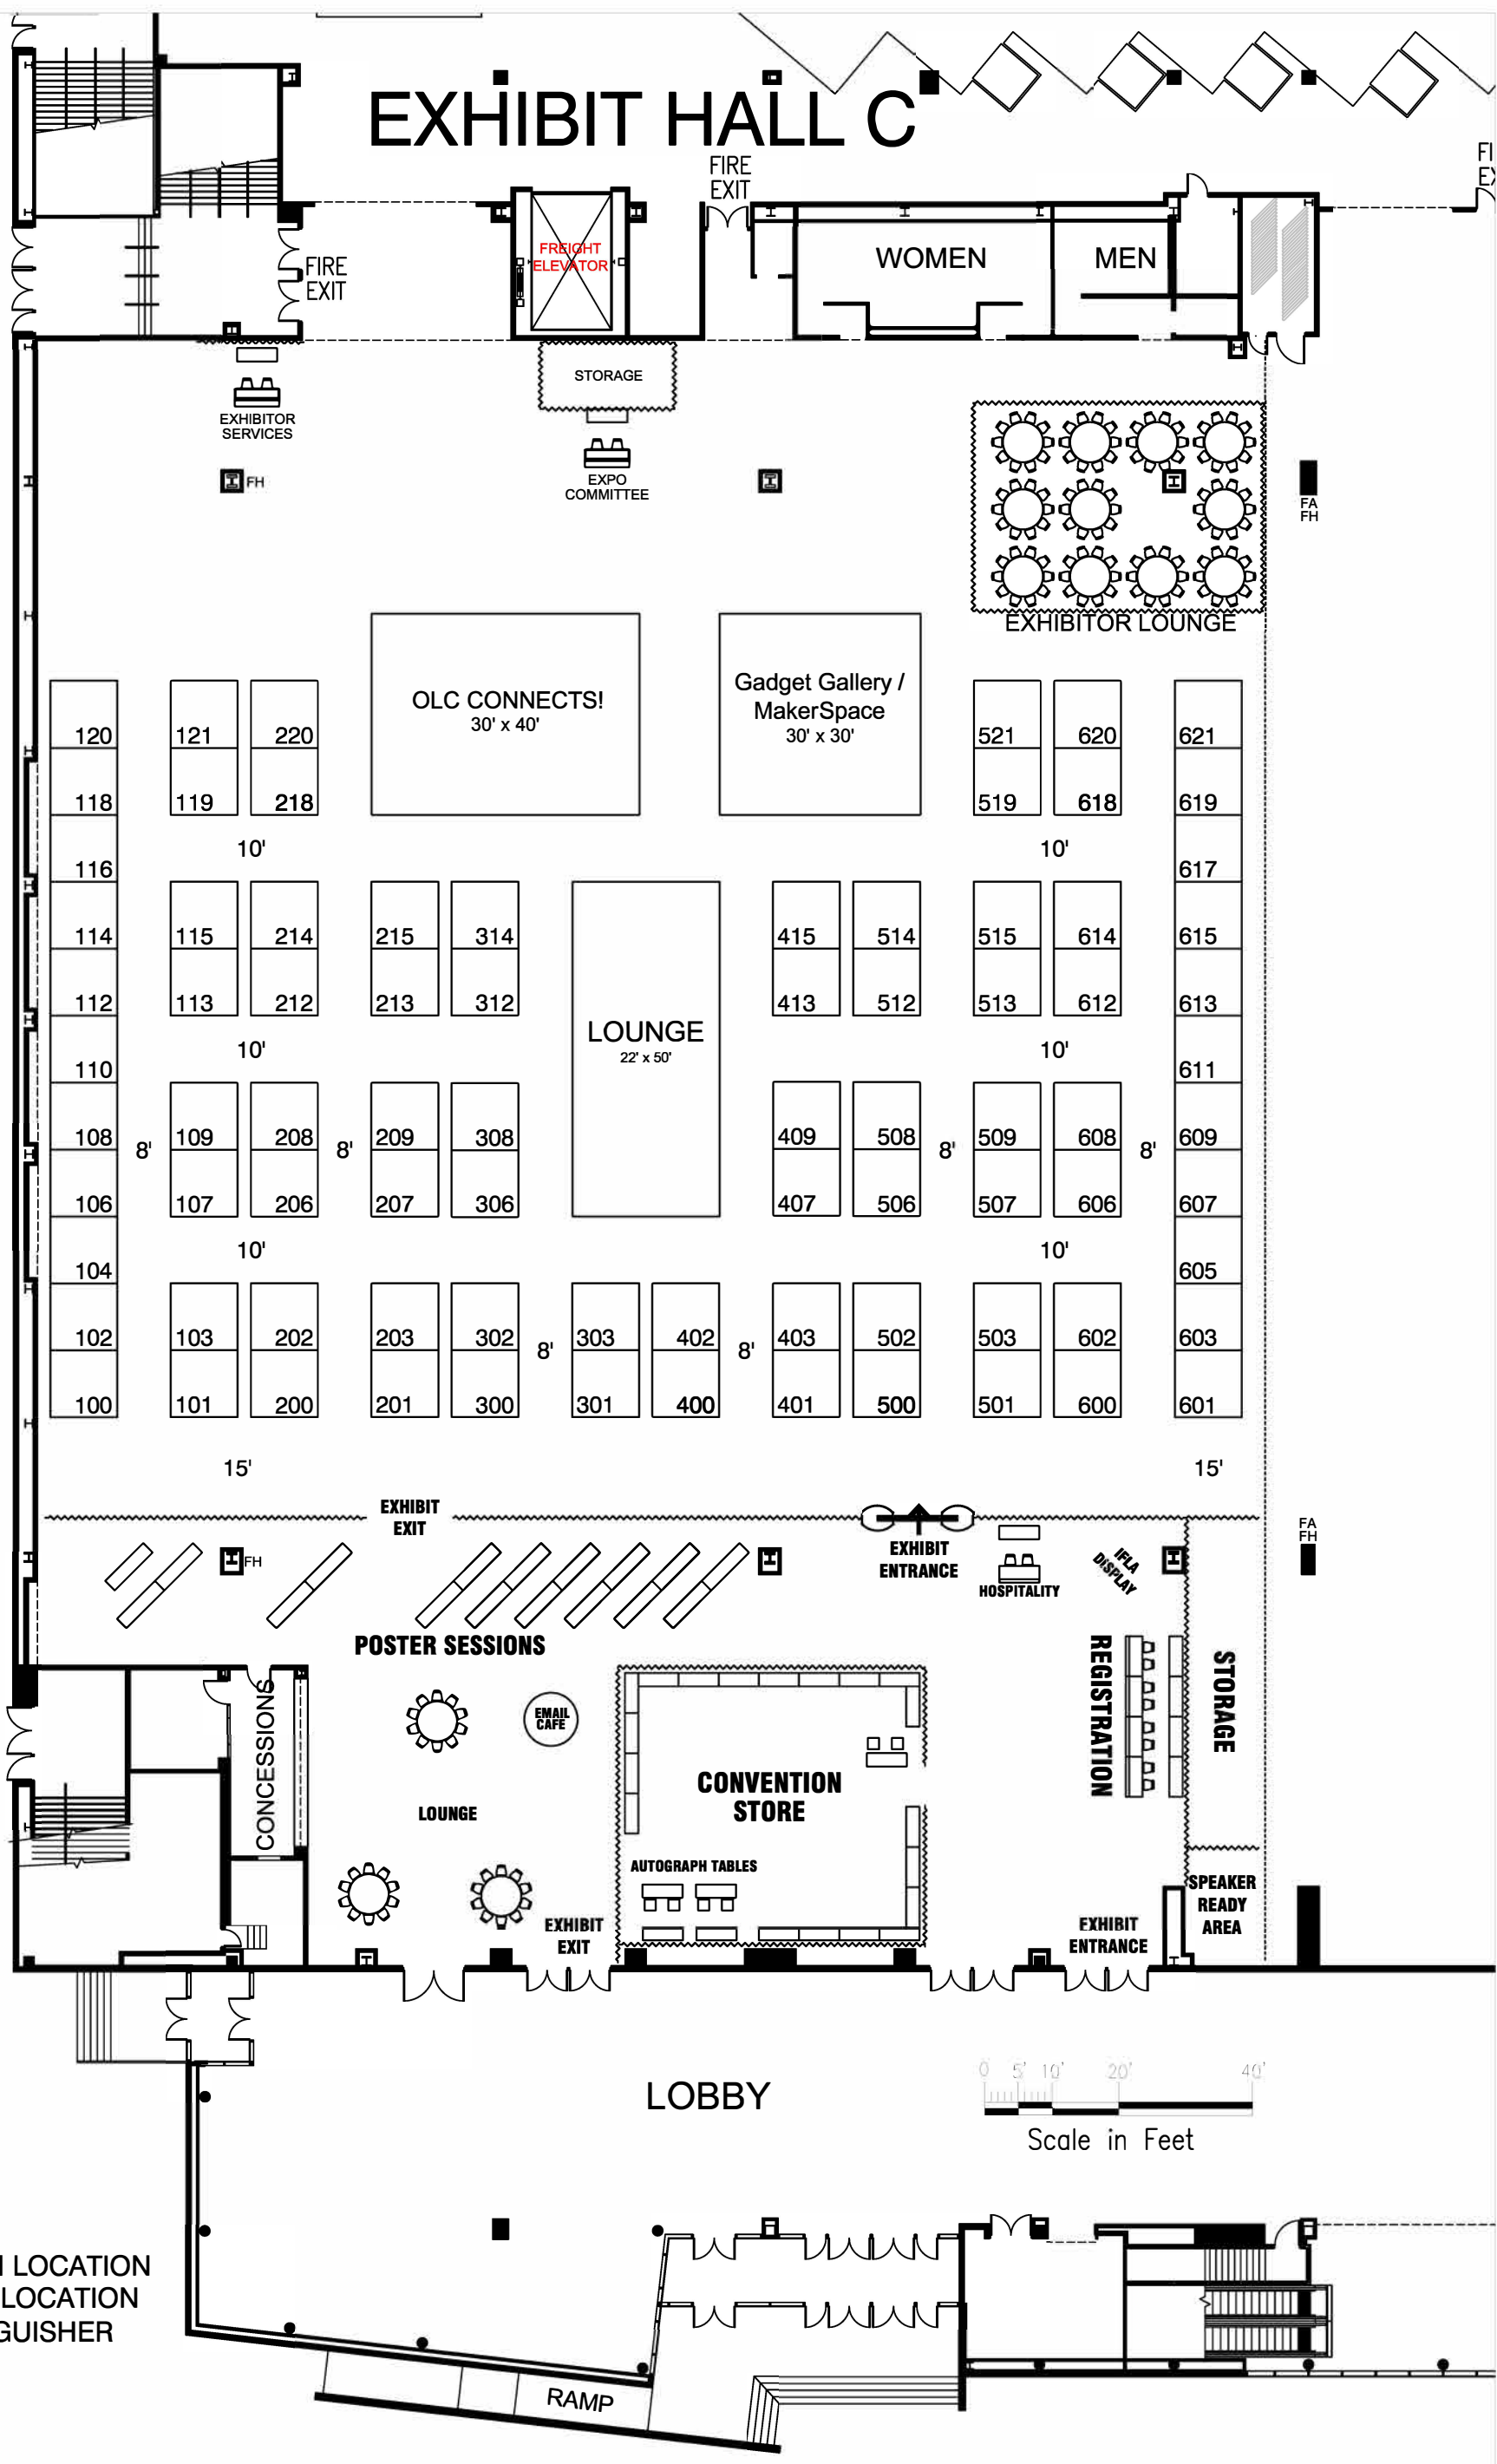


CENTRAL AVENUE

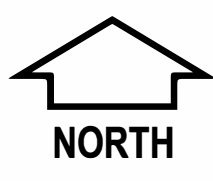

NORTH

## LEGEND

- FA - FIRE ALARM LOCATION
- FH - FIRE HOSE LOCATION
- FE - FIRE EXTINGUISHER

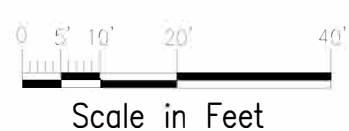

## Ohio Library Council Conference & Expo 2019 September 25 - 27, 2019

Facility: Duke Energy Convention Center	Drawn By: Bob Koenig
City & State: Cincinnati, OH	Show Number: 0526-02-19
Room Location: Exhibit Hall C	Revised: 1/04/19
A.E. Jeff Lockshine	Drawing File: 0526-02-19 OLC r3 1-04-19

Legend:

Inventory as of 01/04/2019	
Dimension	Qty
10'x10'	82
<b>Totals:</b>	<b>82</b>

**fern**  
645 Linn Street  
Cincinnati, OH 45203  
ph: 513-333-7060  
fax: 513-333-7067

Every effort has been made to ensure the accuracy of all information contained on this floor plan. However, no warranties, either expressed or implied are made with respect to this floor plan. If the location of building columns, utilities or other architectural components of the facility is a consideration in the construction of an exhibit, it is the sole responsibility of the exhibitor to physically inspect the facility to verify all dimensions and locations.